


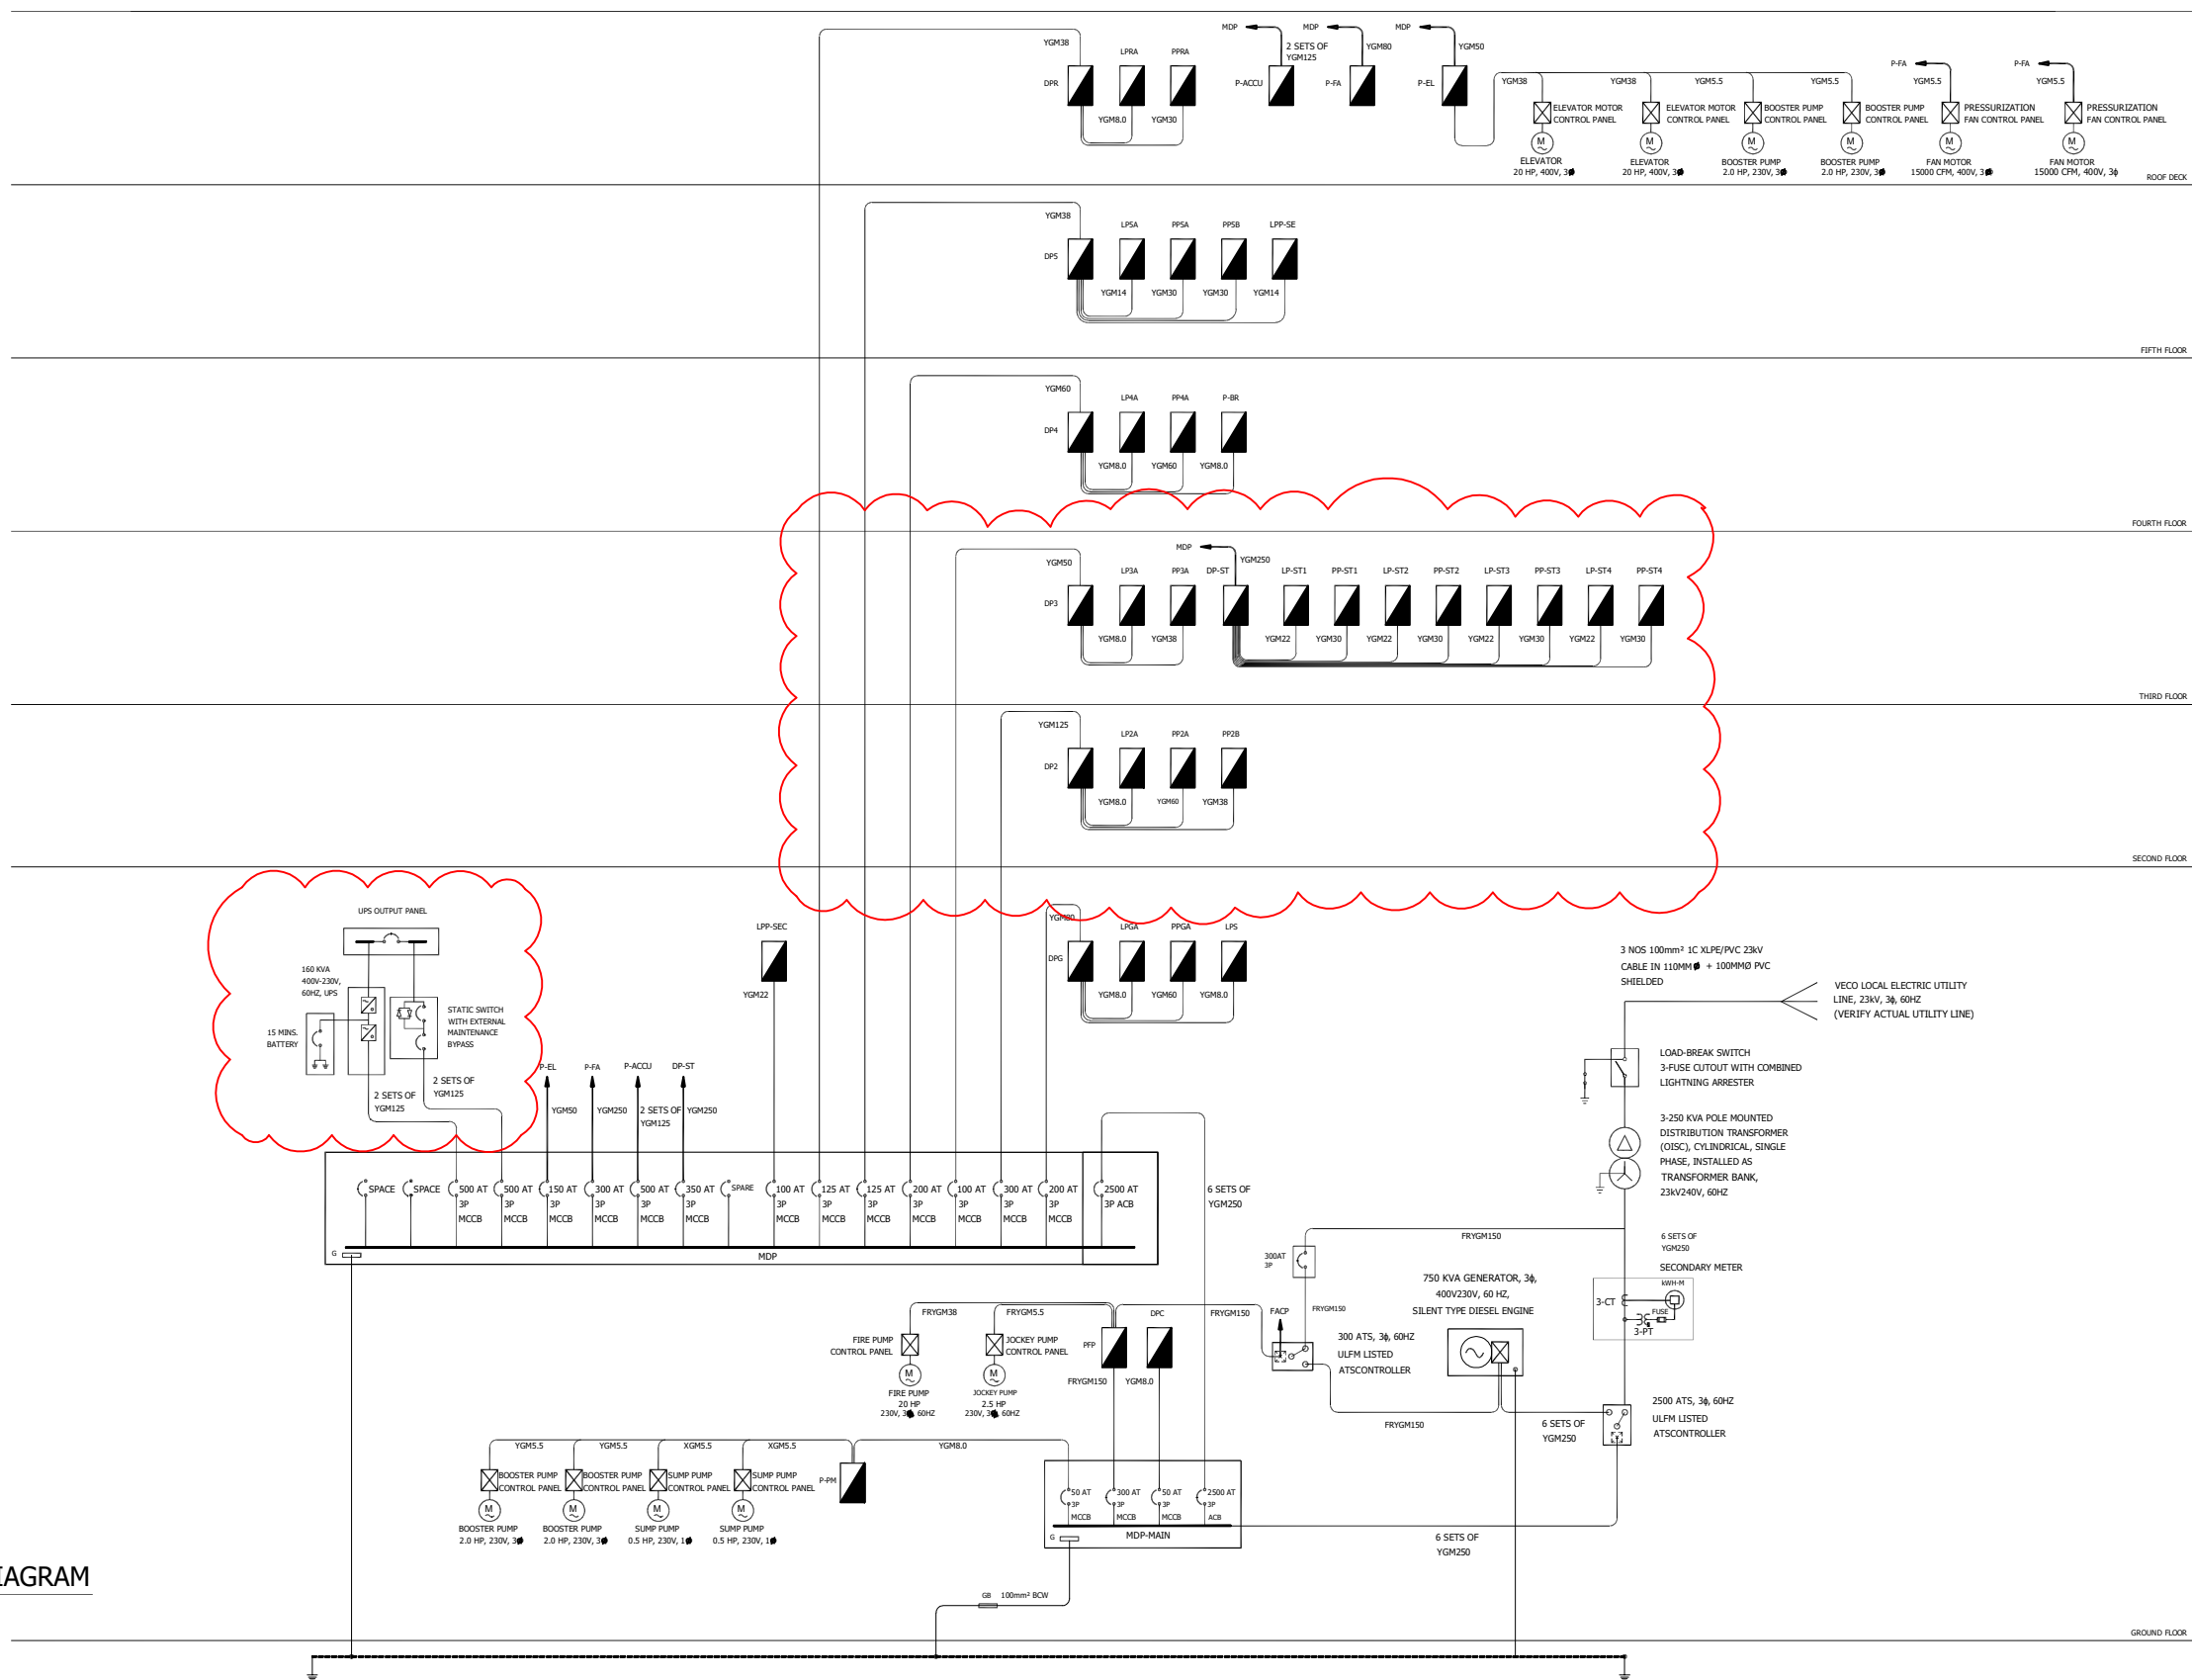

01 ELECTRICAL RISER DIAGRAM
E-102.0 SCALE: NTS



REPUBLIC OF THE PHILIPPINES
DEPARTMENT OF PUBLIC WORKS AND HIGHWAY
REGION VII
SOUTH ROAD PROPERTIES CEBU CITY

PROJECT TITLE/LOCATION:
Local Program, National Building Program, Buildings And
Other Structures - Multipurpose Facilities, Construction of
PCOO Visayas Hub Building in Barangay Subangdaku,
Mandaue City, Cebu

SHEET CONTENTS:
ELECTRICAL RISER DIAGRAM

PREPARED :
KERT BENJ' A. LABRADA
ENGINEER II
DATE:


REVIEWED:
EMMAN REY J. QUIMSON
SECTION CHIEF, BRIDGES AND OTHER
PUBLIC WORKS DESIGN SECTION
DATE:

SUBMITTED :
NONATO M. PAYLADO
CHIEF, PLANNING & DESIGN DIVISION
DATE:

RECOMMENDED :
MARIO M. MONTEJO, D.M., MNSA
ASSISTANT REGIONAL DIRECTOR
DATE:

APPROVED:
EDGAR B. TABACON, CESO IV
REGIONAL DIRECTOR
DATE:

SET NO.:
01
E102.0
SHEET NO.:
130
218

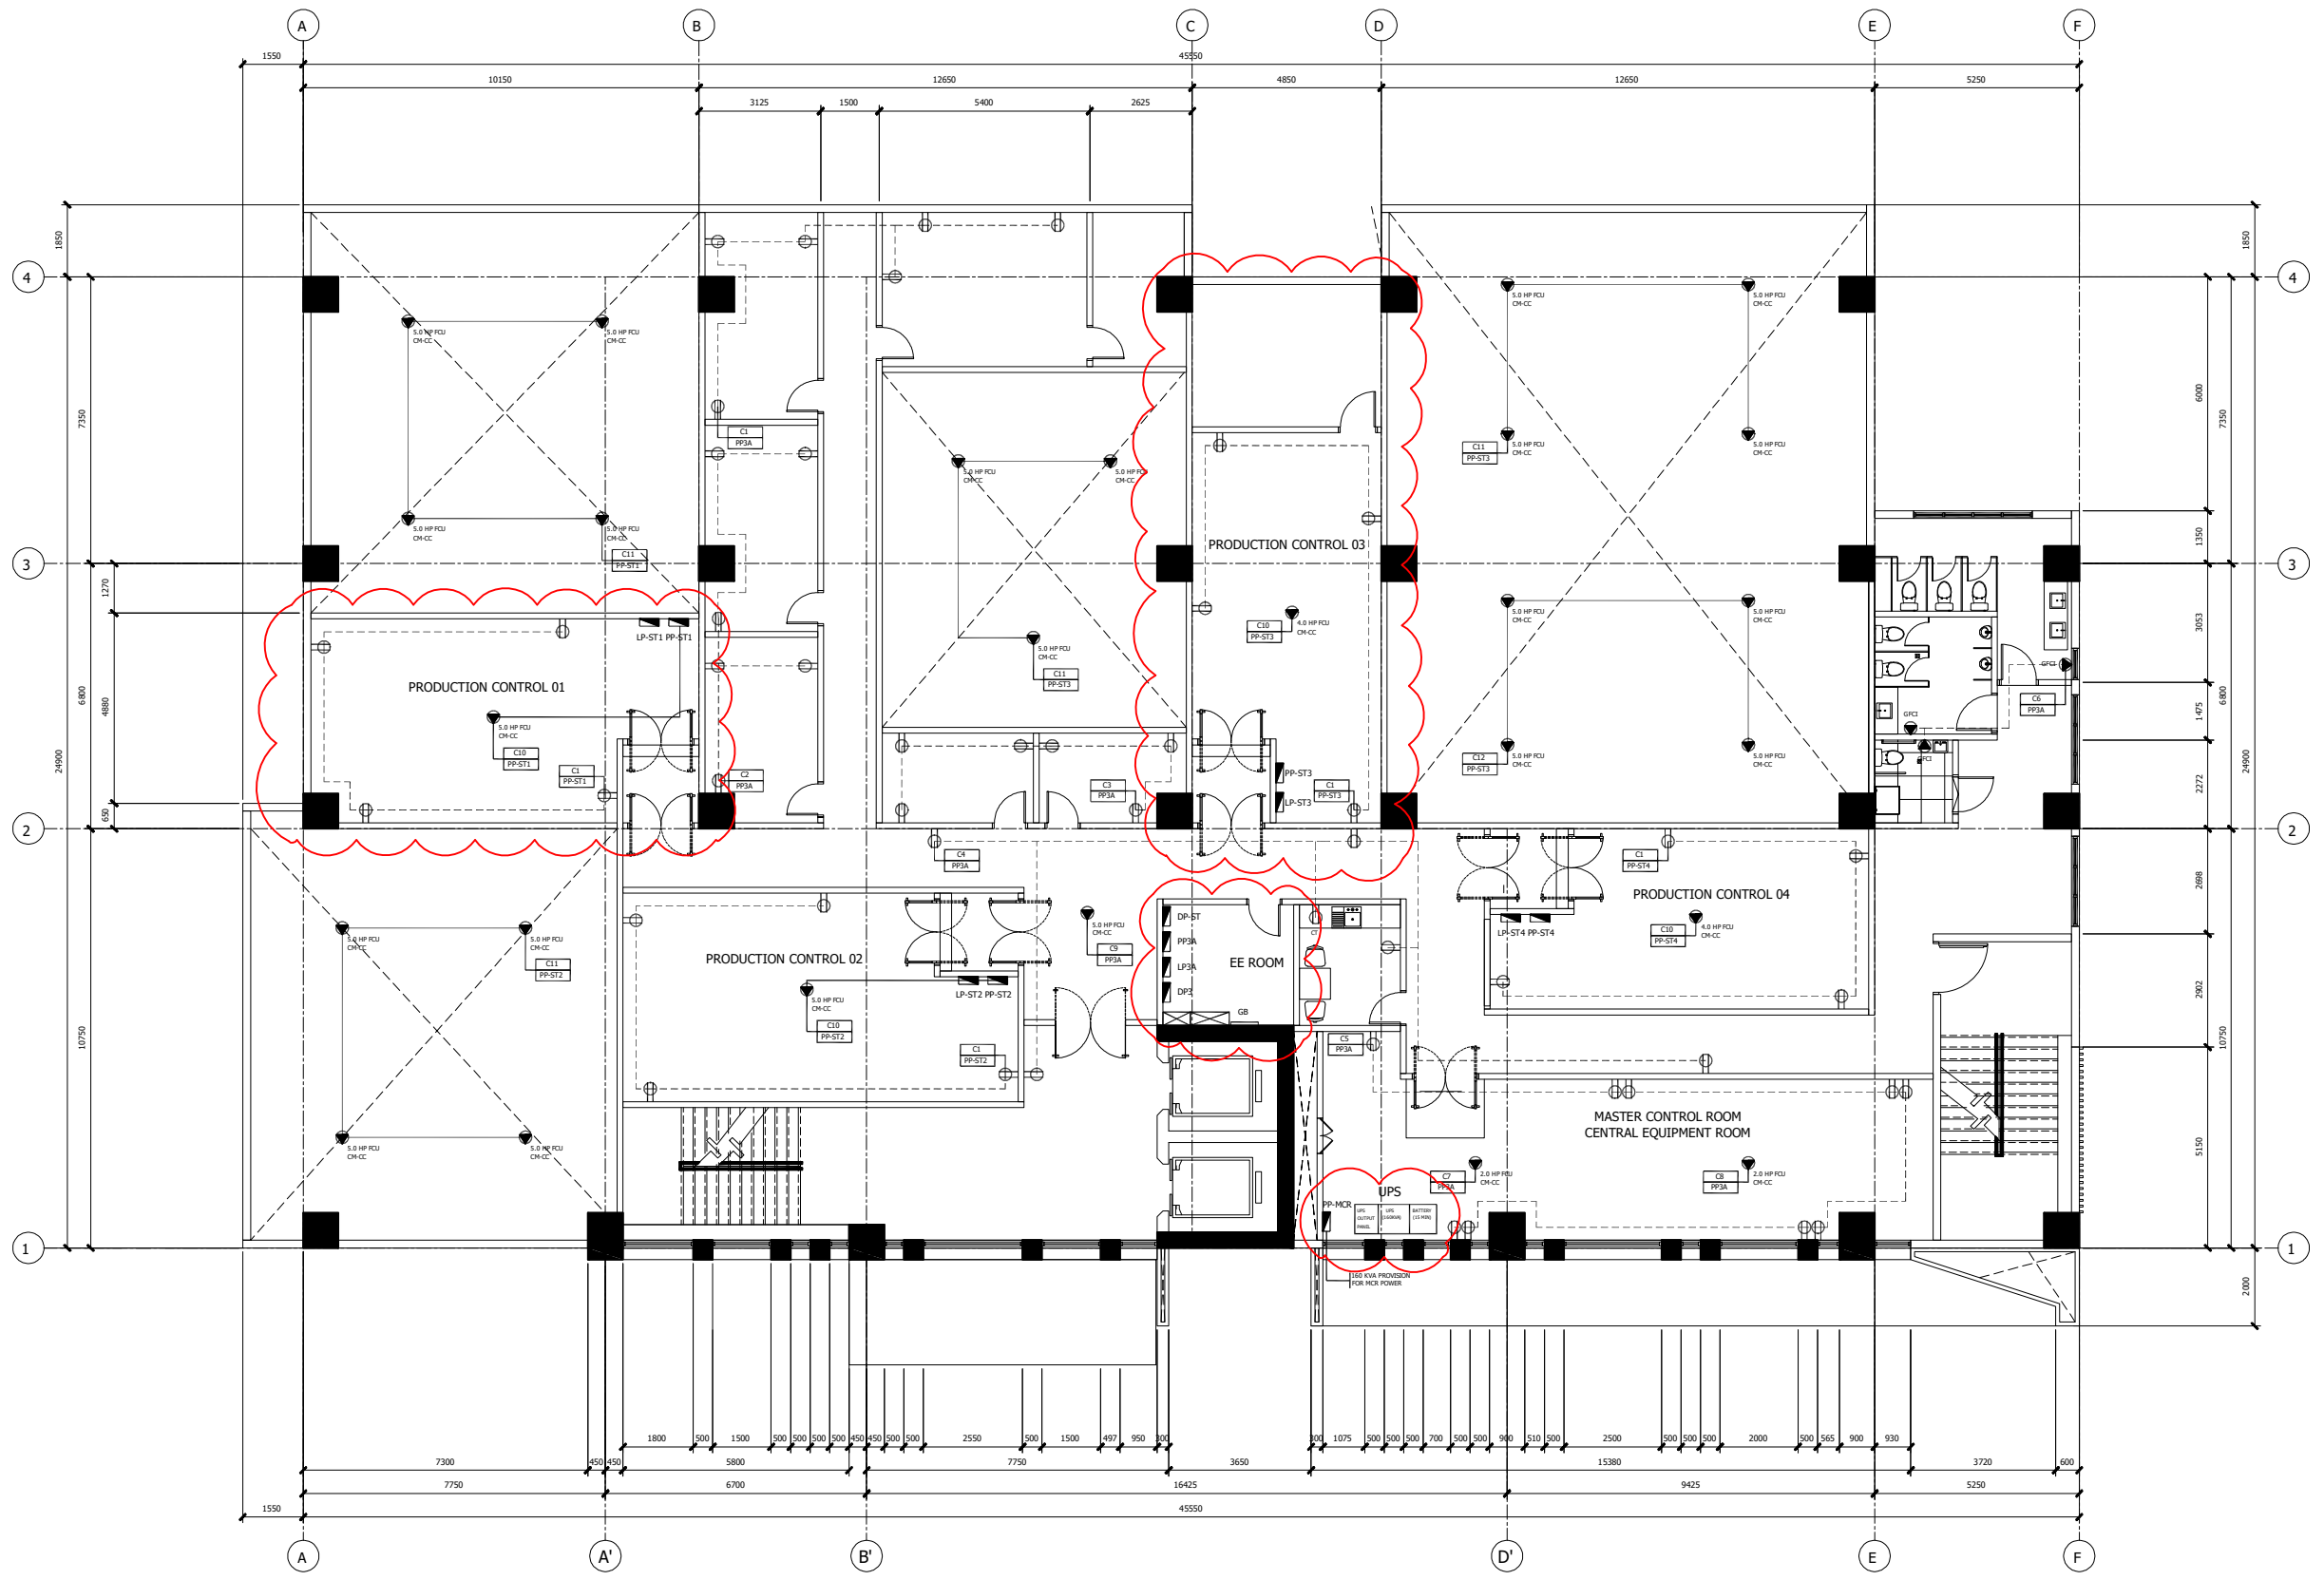

THIRD FLOOR
01 POWER LAYOUT
E-208.0
SCALE: 1:100m



REPUBLIC OF THE PHILIPPINES
DEPARTMENT OF PUBLIC WORKS AND HIGHWAY
REGIONAL OFFICE
REGION VII
SOUTH ROAD PROPERTIES CEBU CITY

PROJECT TITLE/LOCATION:
Local Program, National Building Program, Buildings And
Other Structures - Multipurpose Facilities, Construction of
PCOO Visayas Hub Building in Barangay Subangdaku,
Mandaue City, Cebu

SHEET CONTENTS:
THIRD FLOOR POWER LAYOUT

PREPARED :
KERT BENJ' A. LABRADA
ENGINEER II

REVIEWED:
EMMAN REY J. QUIMSON
SECTION CHIEF, BRIDGES AND OTHER
PUBLIC WORKS DESIGN SECTION
DATE:

SUBMITTED :
NONATO M. PAYLADO
CHIEF, PLANNING & DESIGN DIVISION
DATE:

RECOMMENDED :
MARIO M. MONTEJO, D.M., MNSA
ASSISTANT REGIONAL DIRECTOR
DATE:

APPROVED:
EDGAR B. TABACON, CESO IV
REGIONAL DIRECTOR
DATE:

SET NO.:	SHEET NO.:
01 E208.0	140 218